
 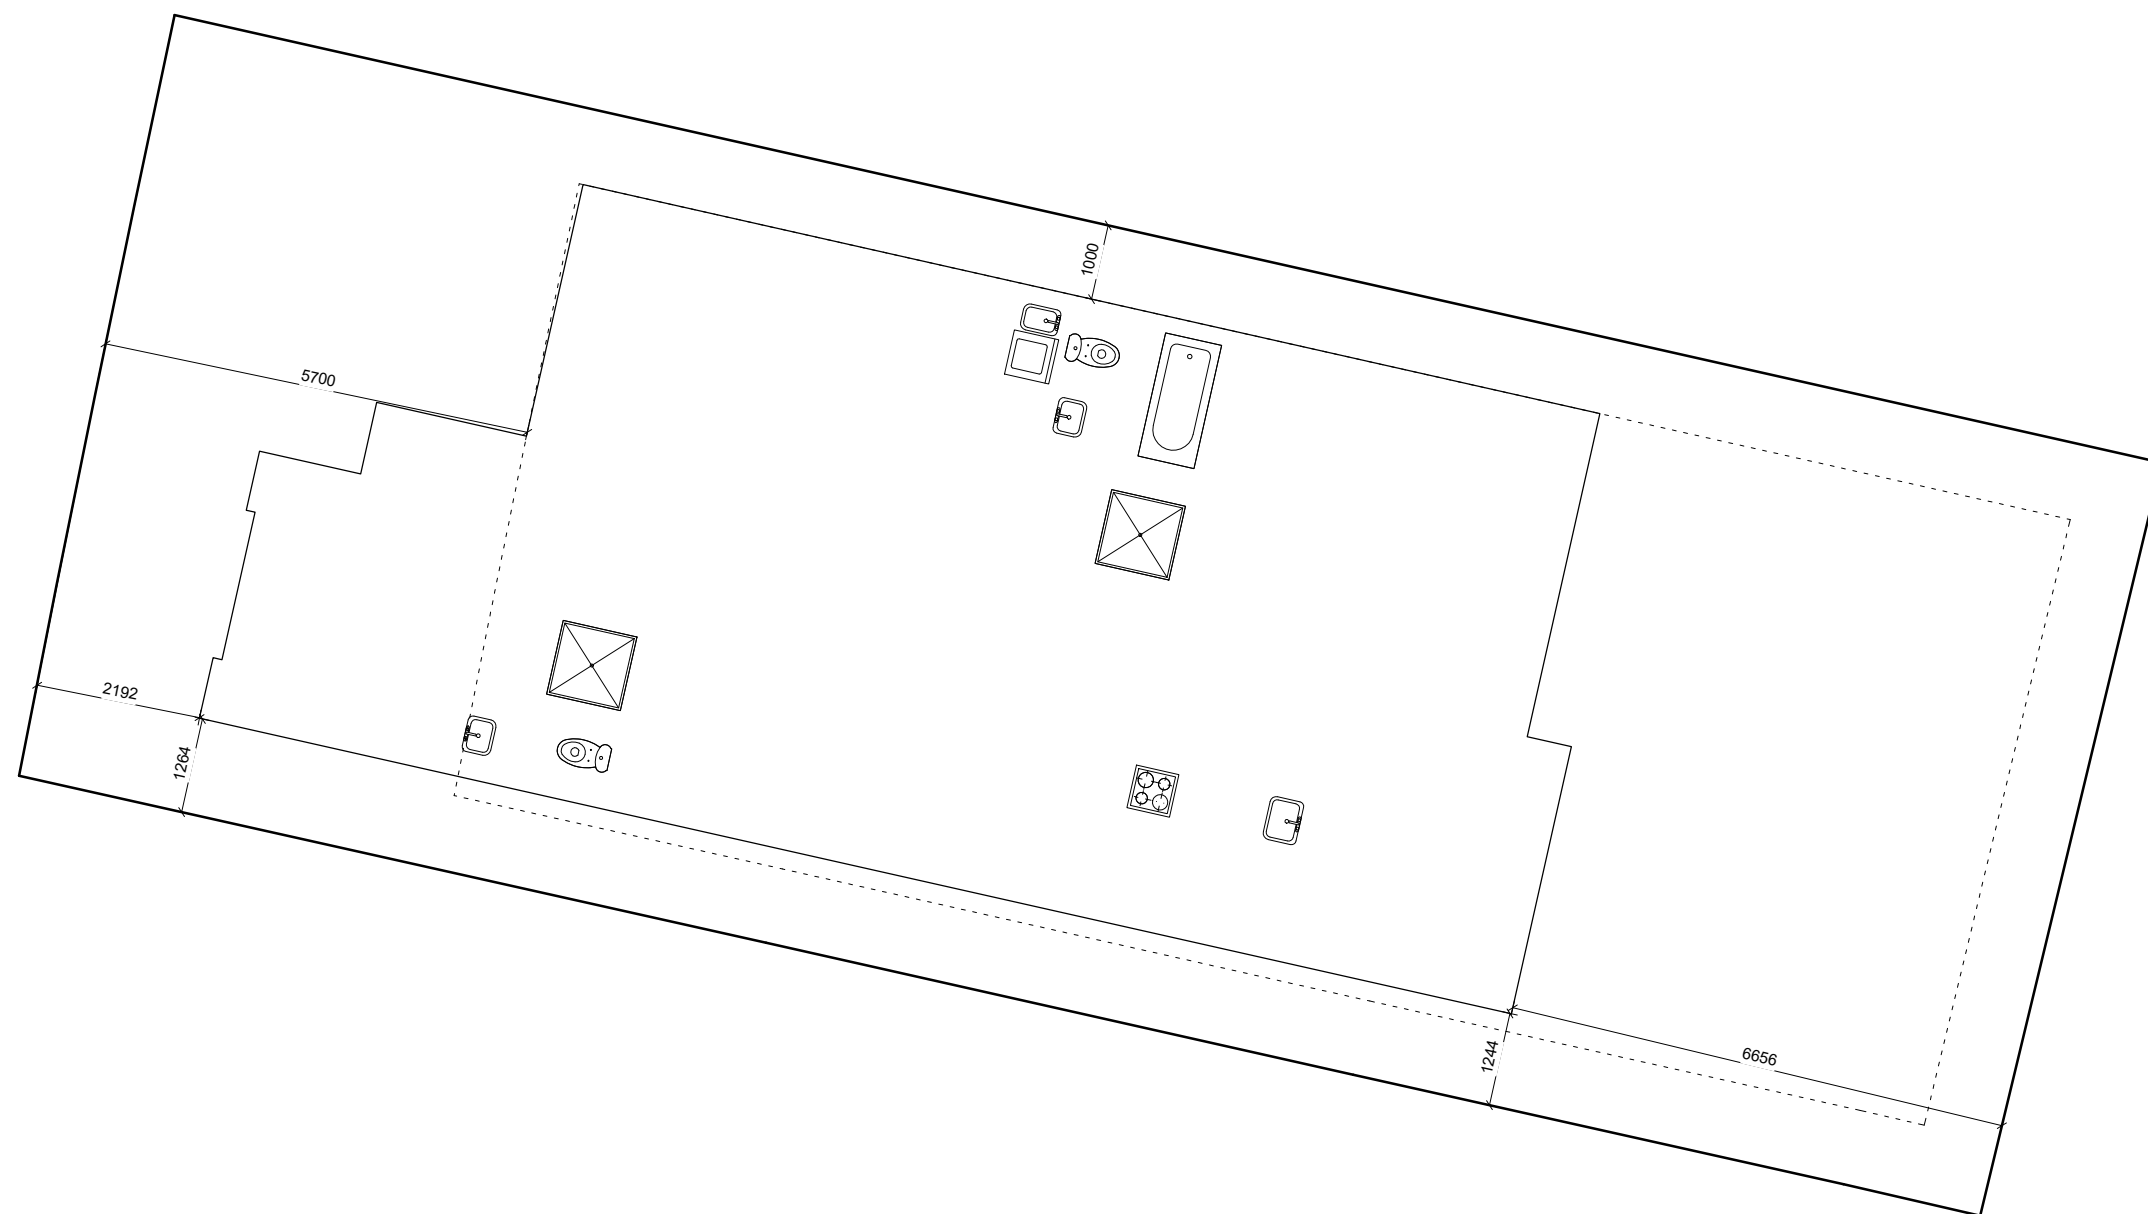



NOTE: ALL DIMENSIONS AND INFORMATION TO BE CONFIRMED ON SITE BY CONTRACTOR

Address: Kenepuru Subdivision Proposed 3 Bedroom Stand-Alone	Drawing: Lot 95 - Proposed New Dwelling Gross Floor Area: 126.529m ²	Drawn Date: 10.09.2018	Drawn By: J. Clegg	Checked By: 101 Homes	Drawn Scale: 1 : 100	Sheet No: Revision: 000
---	---	----------------------------------	------------------------------	---------------------------------	--------------------------------	--------------------------------------




NOTE: ALL DIMENSIONS AND INFORMATION TO BE CONFIRMED ON SITE BY CONTRACTOR


Address: Kenepuru Subdivision Proposed 3 Bedroom Stand-Alone	Drawing: Lot 95 - Site Plan	Drawn Date: 10.09.2018	Drawn By: J. Clegg	Checked By: 101 Homes	Drawn Scale: 1 : 100	Sheet No: Revision: 100
---	------------------------------------	----------------------------------	------------------------------	---------------------------------	--------------------------------	--------------------------------------

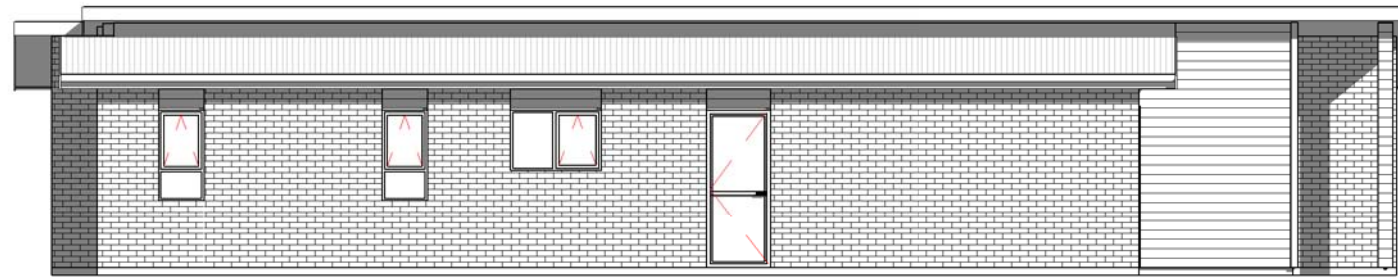

N North
1 : 100

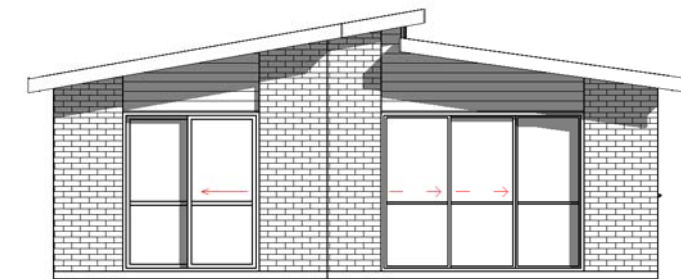

E East
1 : 100

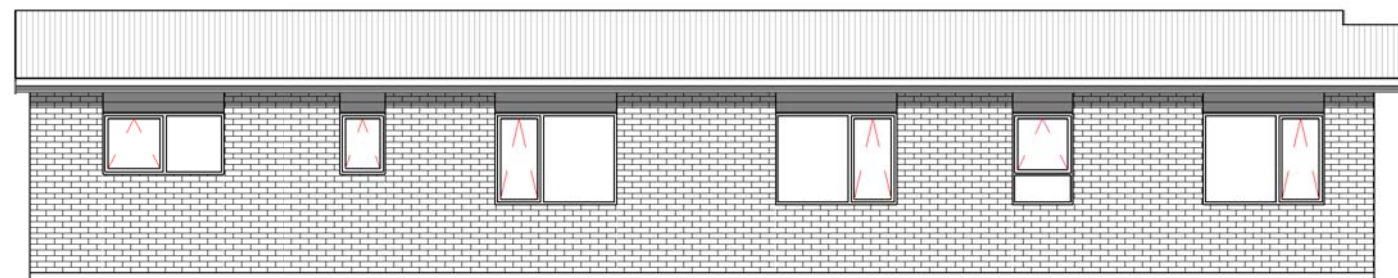


S South
1 : 100



W West
1 : 100





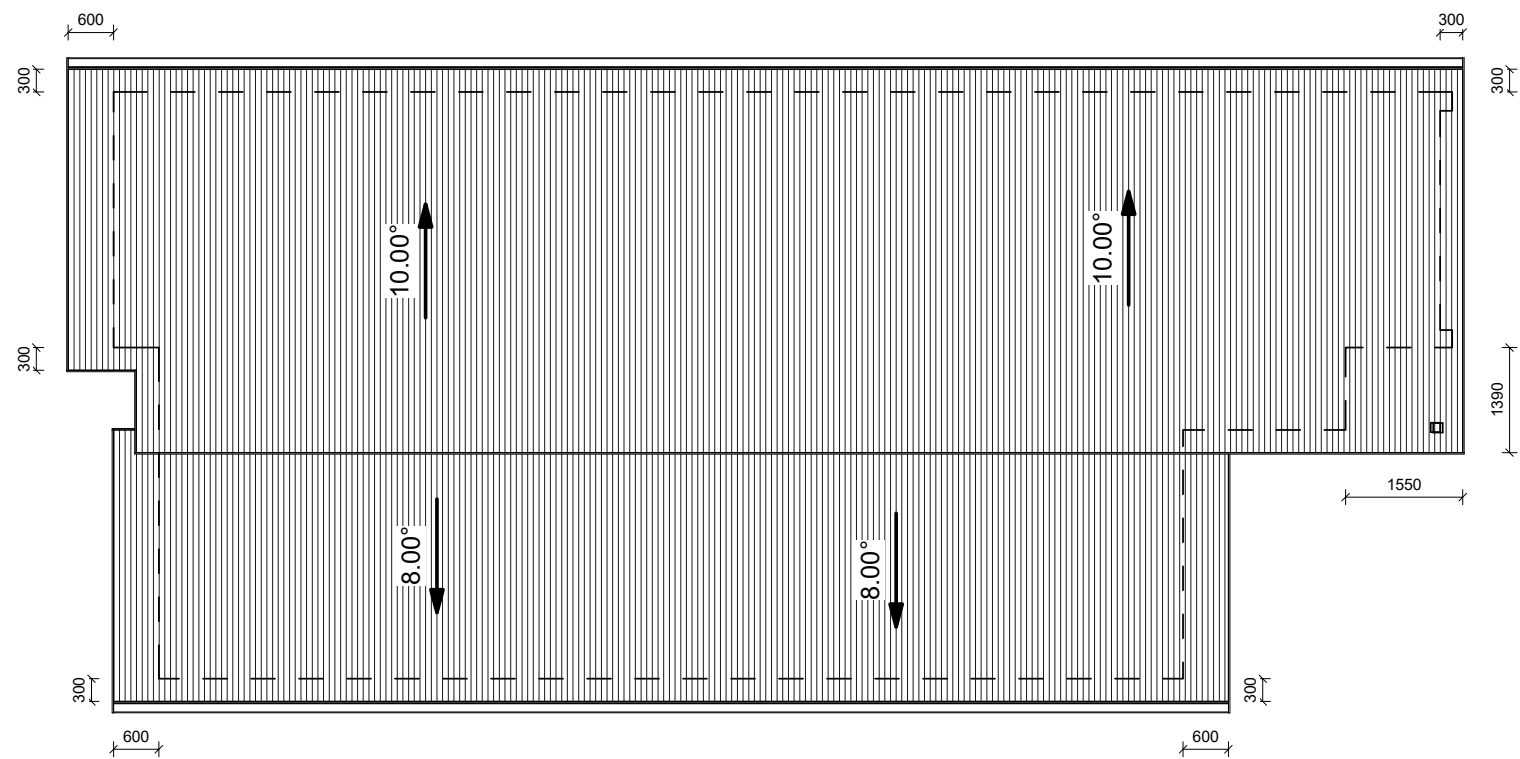














NOTE: ALL DIMENSIONS AND INFORMATION TO BE CONFIRMED ON SITE BY CONTRACTOR


Address: Kenepuru Subdivision Proposed 3 Bedroom Stand-Alone	Drawing: Lot 95 - Elevations	Drawn Date: 10.09.2018	Drawn By: J. Clegg	Checked By: 101 Homes	Drawn Scale: 1 : 100	Sheet No: Revision:
---	-------------------------------------	---------------------------	-----------------------	--------------------------	-------------------------	------------------------



NOTE: ALL DIMENSIONS AND INFORMATION TO BE CONFIRMED ON SITE BY CONTRACTOR

Address: Kenepuru Subdivision Proposed 3 Bedroom Stand-Alone	Drawing: Lot 95 - Roof Plan	Drawn Date: 10.09.2018	Drawn By: J. Clegg	Checked By: 101 Homes	Drawn Scale: 1 : 100	Sheet No: Revision: 130
---	------------------------------------	----------------------------------	------------------------------	---------------------------------	--------------------------------	--------------------------------------

SYMBOL KEY	
	= LED DOWN LIGHT
	= WALL LIGHT
	= POWER OUTLET (DOUBLE, SWITCHED)
	= APPLIANCE POWER OUTLET
	= SWITCH -NUMBER = NUMBER OF GANGS
	= 3 WAY SWITCH
	= EXTRACTOR FAN
	= SENSOR SWITCH
	= OUTDOOR SENSOR
	= ALARM SENSOR
	= ALARM PANEL
	= ALARM KEYPAD
	= TV/SKY/DATA
	= TV
	= GARAGE DOOR SWITCH
	= DATA POINT
	= PHOTOELECTRIC SMOKE DETECTOR AS PER NZBC:F7
	= COMBINATION SWITCH & METER BOARD
	= DATA, TV, PHONE ETC HUB

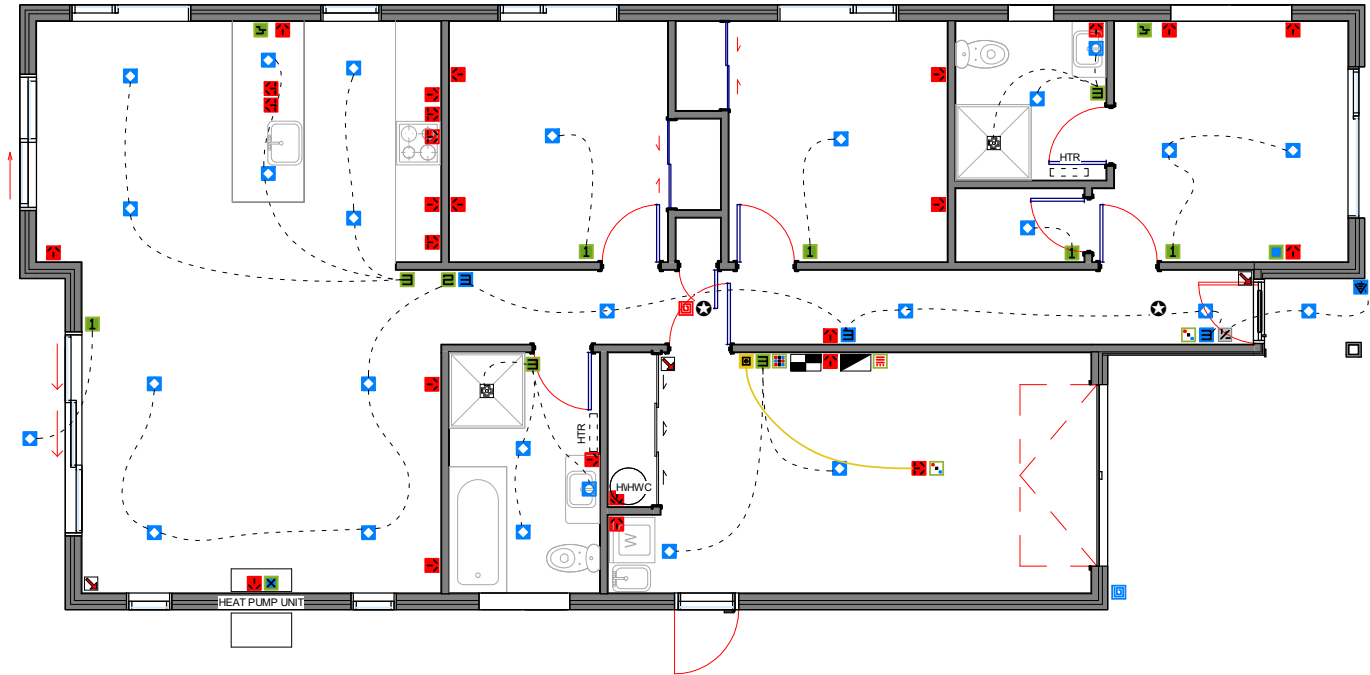

NOTE: ALL DIMENSIONS AND INFORMATION TO BE CONFIRMED ON SITE BY CONTRACTOR

Address: Kenepuru Subdivision Proposed 3 Bedroom Stand-Alone	Drawing: Lot 95 - Electrical Plan	Drawn Date: 10.09.2018	Drawn By: J. Clegg	Checked By: 101 Homes	Drawn Scale: 1 : 100	Sheet No: Revision: 190
---	--	----------------------------------	------------------------------	---------------------------------	--------------------------------	--------------------------------------