

NOTE: ALL DIMENSIONS AND INFORMATION TO BE CONFIRMED ON SITE BY CONTRACTOR

Address: **Kenepuru Subdivision**  
**Proposed 3 Bedroom Stand-Alone**

Drawing: **Lot 107 - Proposed New Dwelling**  
Gross Floor Area: 126.769m<sup>2</sup>


Drawn Date:  
**10.09.2018**

Drawn By:  
**J. Clegg**

Checked By:  
**101 Homes**

Drawn Scale:  
**1 : 100**

Sheet No:  
Revision: **000**

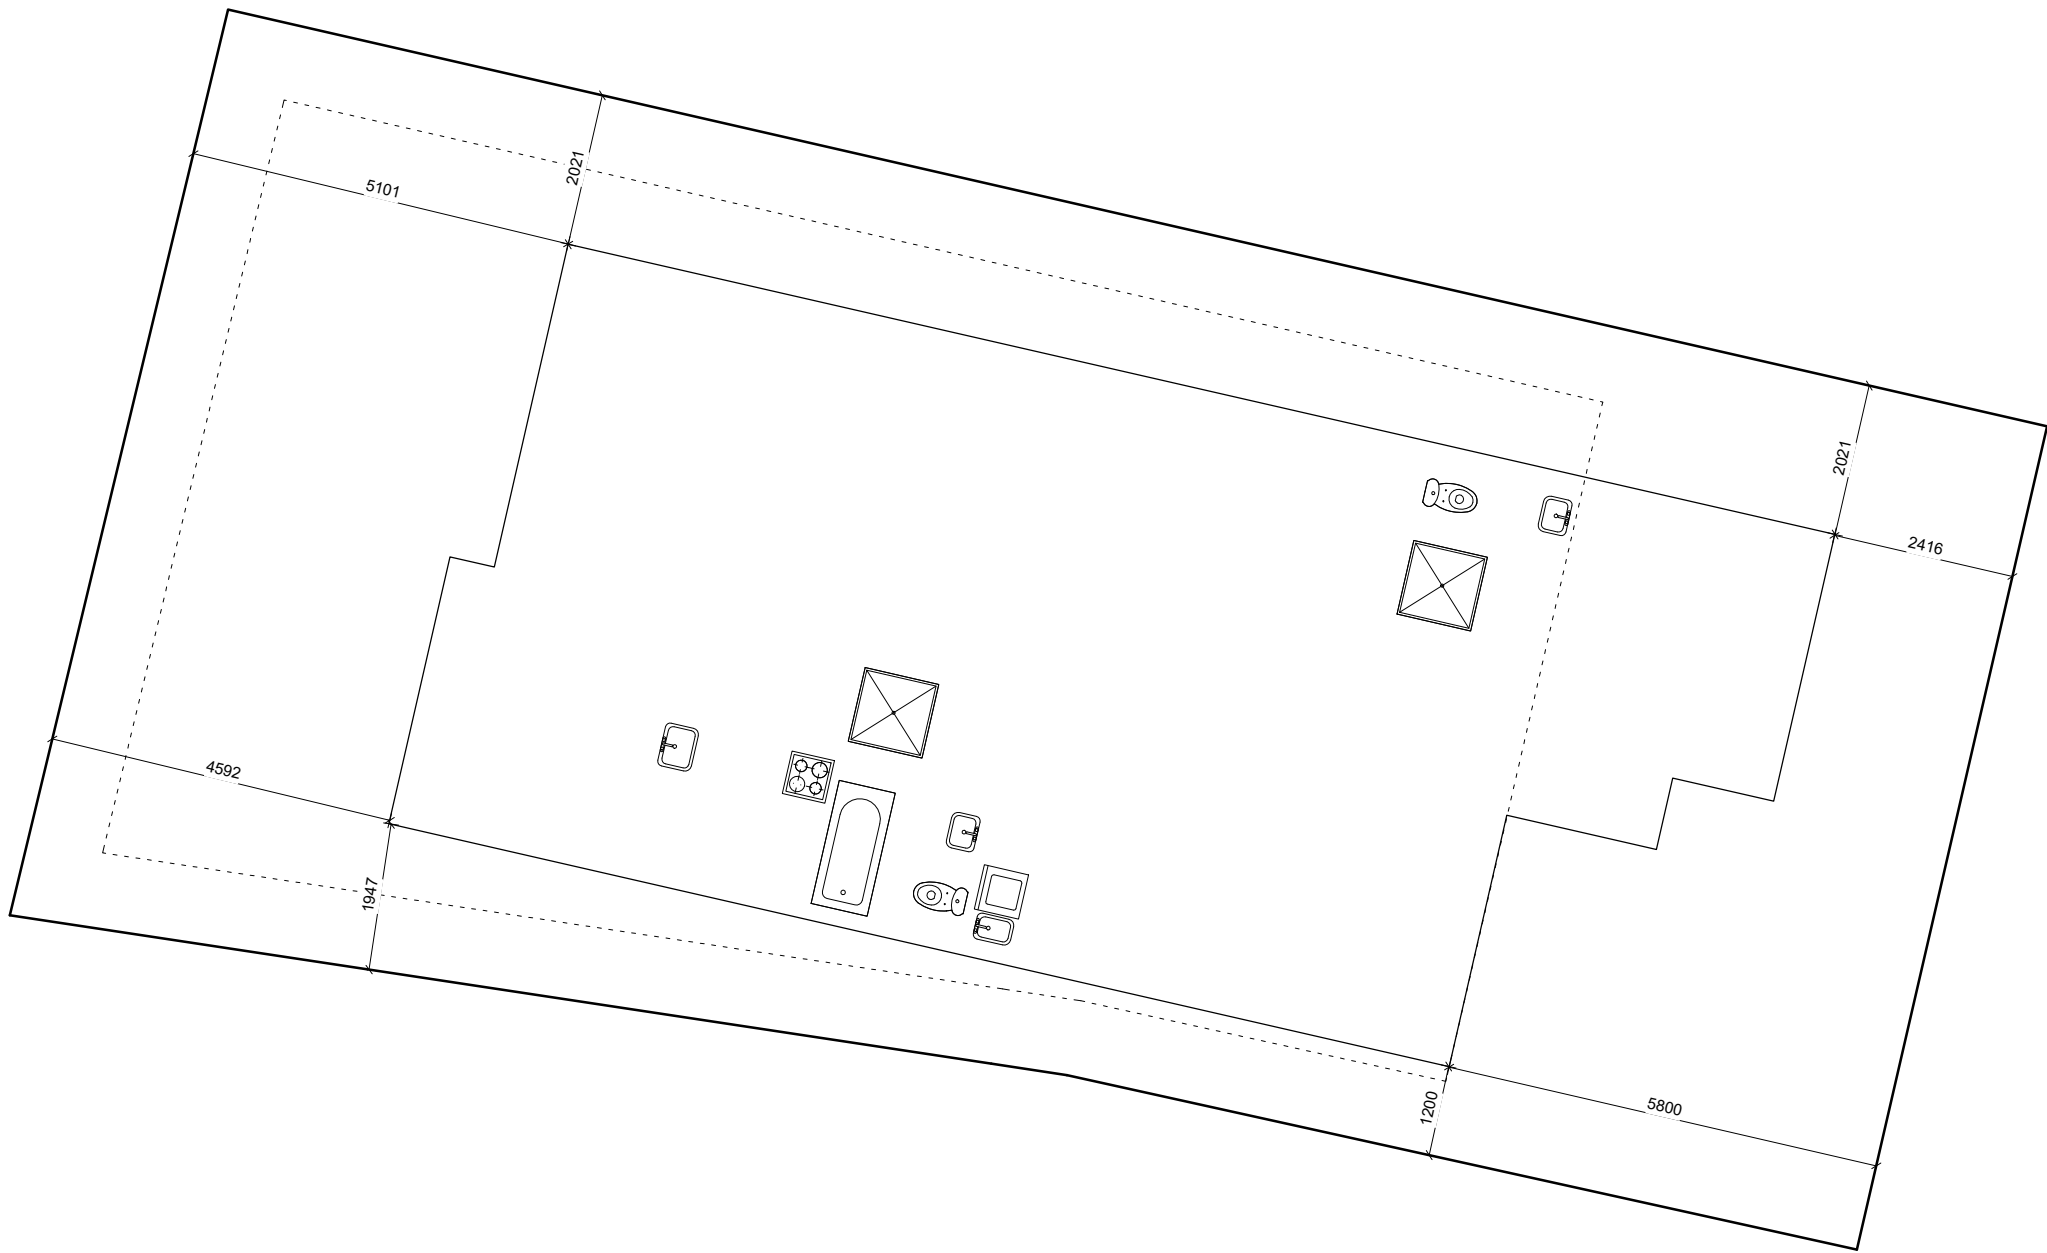

NOTE: ALL DIMENSIONS AND INFORMATION TO BE CONFIRMED ON SITE BY CONTRACTOR


Address: <b>Kenepuru Subdivision</b> <b>Proposed 3 Bedroom Stand-Alone</b>	Drawing: <b>Lot 107 - Site Plan</b>	Drawn Date: <b>10.09.2018</b>	Drawn By: <b>J. Clegg</b>	Checked By: <b>Topcat Design Ltd</b>	Drawn Scale: <b>1 : 100</b>	Sheet No: Revision: <b>100</b>
---	-------------------------------------	----------------------------------	------------------------------	---	--------------------------------	--------------------------------------




W West  
1 : 100



E East  
1 : 100

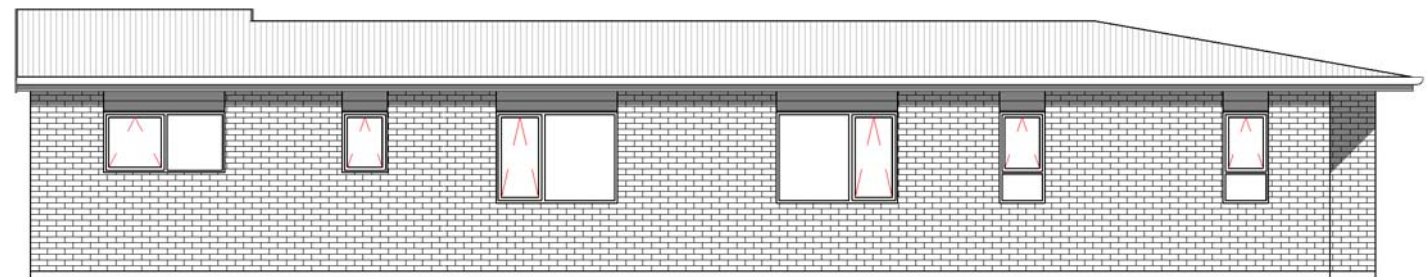

N North  
1 : 100

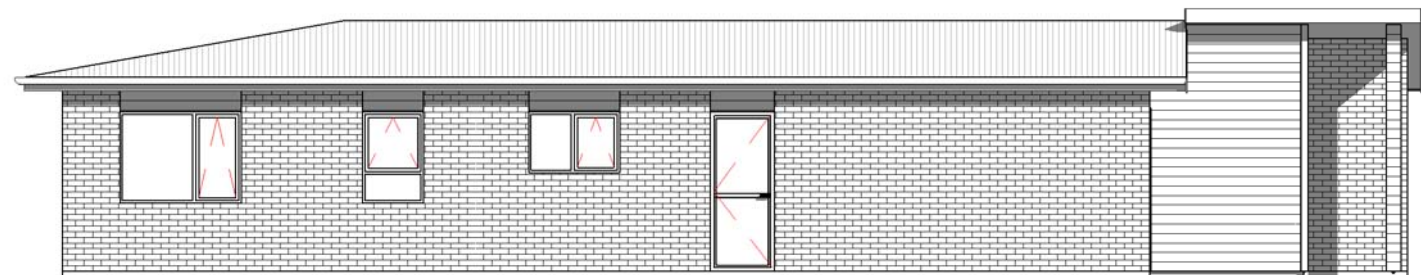

S South  
1 : 100

NOTE: ALL DIMENSIONS AND INFORMATION TO BE CONFIRMED ON SITE BY CONTRACTOR

Address: **Kenepuru Subdivision**  
**Proposed 3 Bedroom Stand-Alone**

Drawing: **Lot 107 - Elevations**


Drawn Date:  
**10.09.2018**

Drawn By:  
**J. Clegg**

Checked By:  
**101 Homes**

Drawn Scale:  
**1 : 100**

Sheet No:  
Revision: **110**

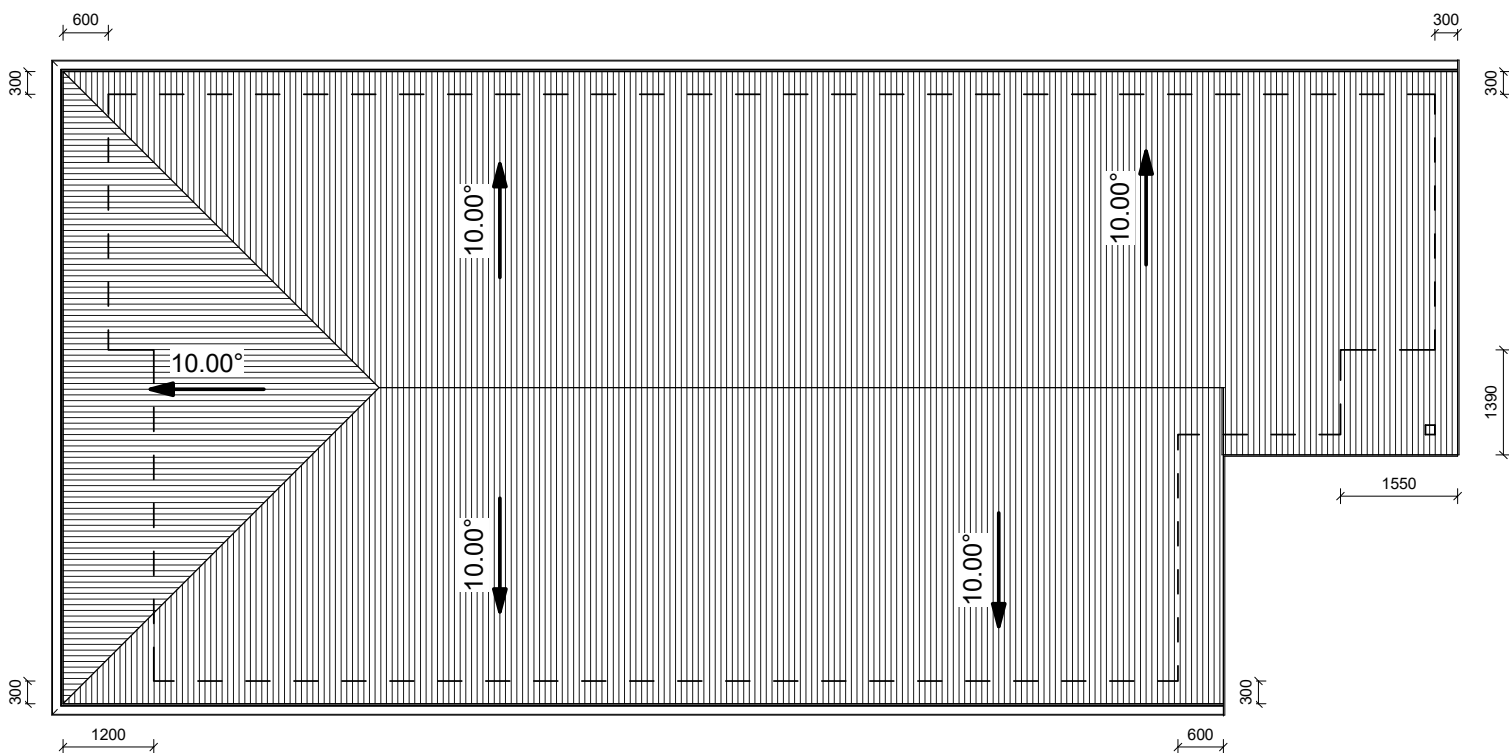

NOTE: ALL DIMENSIONS AND INFORMATION TO BE CONFIRMED ON SITE BY CONTRACTOR

Address: **Kenepuru Subdivision**  
**Proposed 3 Bedroom Stand-Alone**

Drawing: **Lot 107 - Roof Plan**

Drawn Date:  
**10.09.2018**

Drawn By:  
**J. Clegg**

Checked By:  
**101 Homes**

Drawn Scale:  
**1 : 100**

Sheet No:  
Revision: **130**

SYMBOL KEY

= LED DOWN LIGHT

= WALL LIGHT

= POWER OUTLET (DOUBLE, SWITCHED)

= APPLIANCE POWER OUTLET

= SWITCH -NUMBER = NUMBER OF GANGS

= 3 WAY SWITCH

= EXTRACTOR FAN

= SENSOR SWITCH

= OUTDOOR SENSOR

= ALARM SENSOR

= ALARM PANEL

= ALARM KEYPAD

= TV/SKY/DATA

= TV


= GARAGE DOOR SWITCH

= DATA POINT

= PHOTOELECTRIC SMOKE DETECTOR  
AS PER NZBC:F7

= COMBINATION SWITCH & METER  
BOARD

= DATA, TV, PHONE ETC HUB

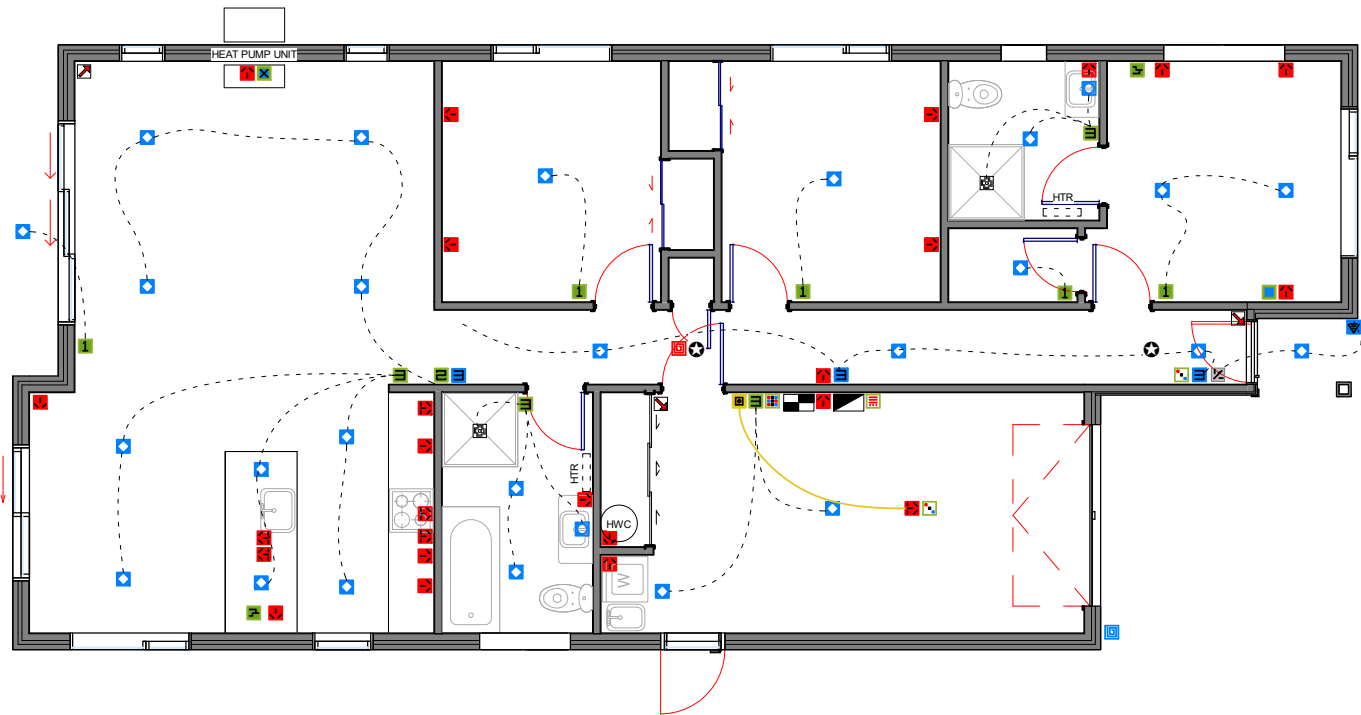

NOTE: ALL DIMENSIONS AND INFORMATION TO BE CONFIRMED ON SITE BY CONTRACTOR